


22ND FLOOR MECHANICAL PLAN
SCALE: 1/8" = 1'-0"

- GENERAL NOTES:**
1. THE PLANS ARE INTENDED TO INDICATE THE GENERAL LOCATION AND FAN COIL UNIT TYPE IN EACH APARTMENT. EXACT UNIT DIMENSIONS, LOCATIONS, & RISER PIPING ARRANGEMENTS MUST BE VERIFIED BY THE INSTALLING CONTRACTOR.
 2. SEE FAN COIL UNIT SCHEDULE FOR UNIT CAPACITIES.
 3. SEE TYPICAL FAN COIL UNIT INSTALLATION DETAIL (DWG M-6) FOR INSTALLATION REQUIREMENTS.

THIS PLAN IS APPROVED ONLY FOR WORK INDICATED ON THE APPLICATION SPECIFICATION SHEET. ALL OTHER MATTERS SHOWN ARE NOT TO BE RELIED UPON, OR TO BE CONSIDERED AS EITHER BEING APPROVED OR IN ACCORDANCE WITH APPLICABLE CODES.

Lilker Associates

1001 Avenue of the Americas
New York, NY 10018
tel 212.695.1000
fax 212.695.1299
www.lilker.com

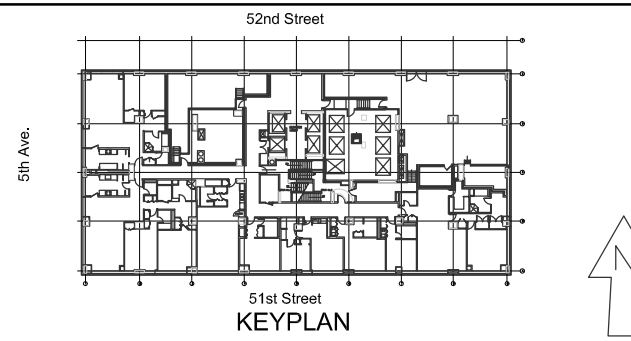

NO.	ISSUE/REVISION	DATE	BY
PROJECT #:		O1961	
DATE:		10-10-07	
SCALE:		$\frac{1}{8}'' = 1'-0''$	
DESIGNED BY:			
DRAWN BY:		DW	
REVIEWED BY:		VR	
APPROVED BY:			
PROJECT TITLE:		PE SEAL ABOVE	
OLYMPIC TOWER FAN COIL REPLACEMENT			
DRAWING TITLE:			
22 TH FLOOR MECHANICAL PLAN			
DRAWING NO.			
M-1			