 


---

1001 Avenue of the Americas  
New York, NY 10018  
tel 212.695.1000  
fax 212.695.1299  
www.jilker.com

[illegible]

DRAWN BY: DW  
REVIEWED BY: VR  
APPROVED BY:


	PE SEAL ABOVE
--	---------------

OLYMPIC TOWER  
FAN COIL  
REPLACEMENT

DRAWING TITLE:  
**50<sup>TH</sup> FLOOR  
MECHANICAL PLAN**

DRAFTING NO.

M-4

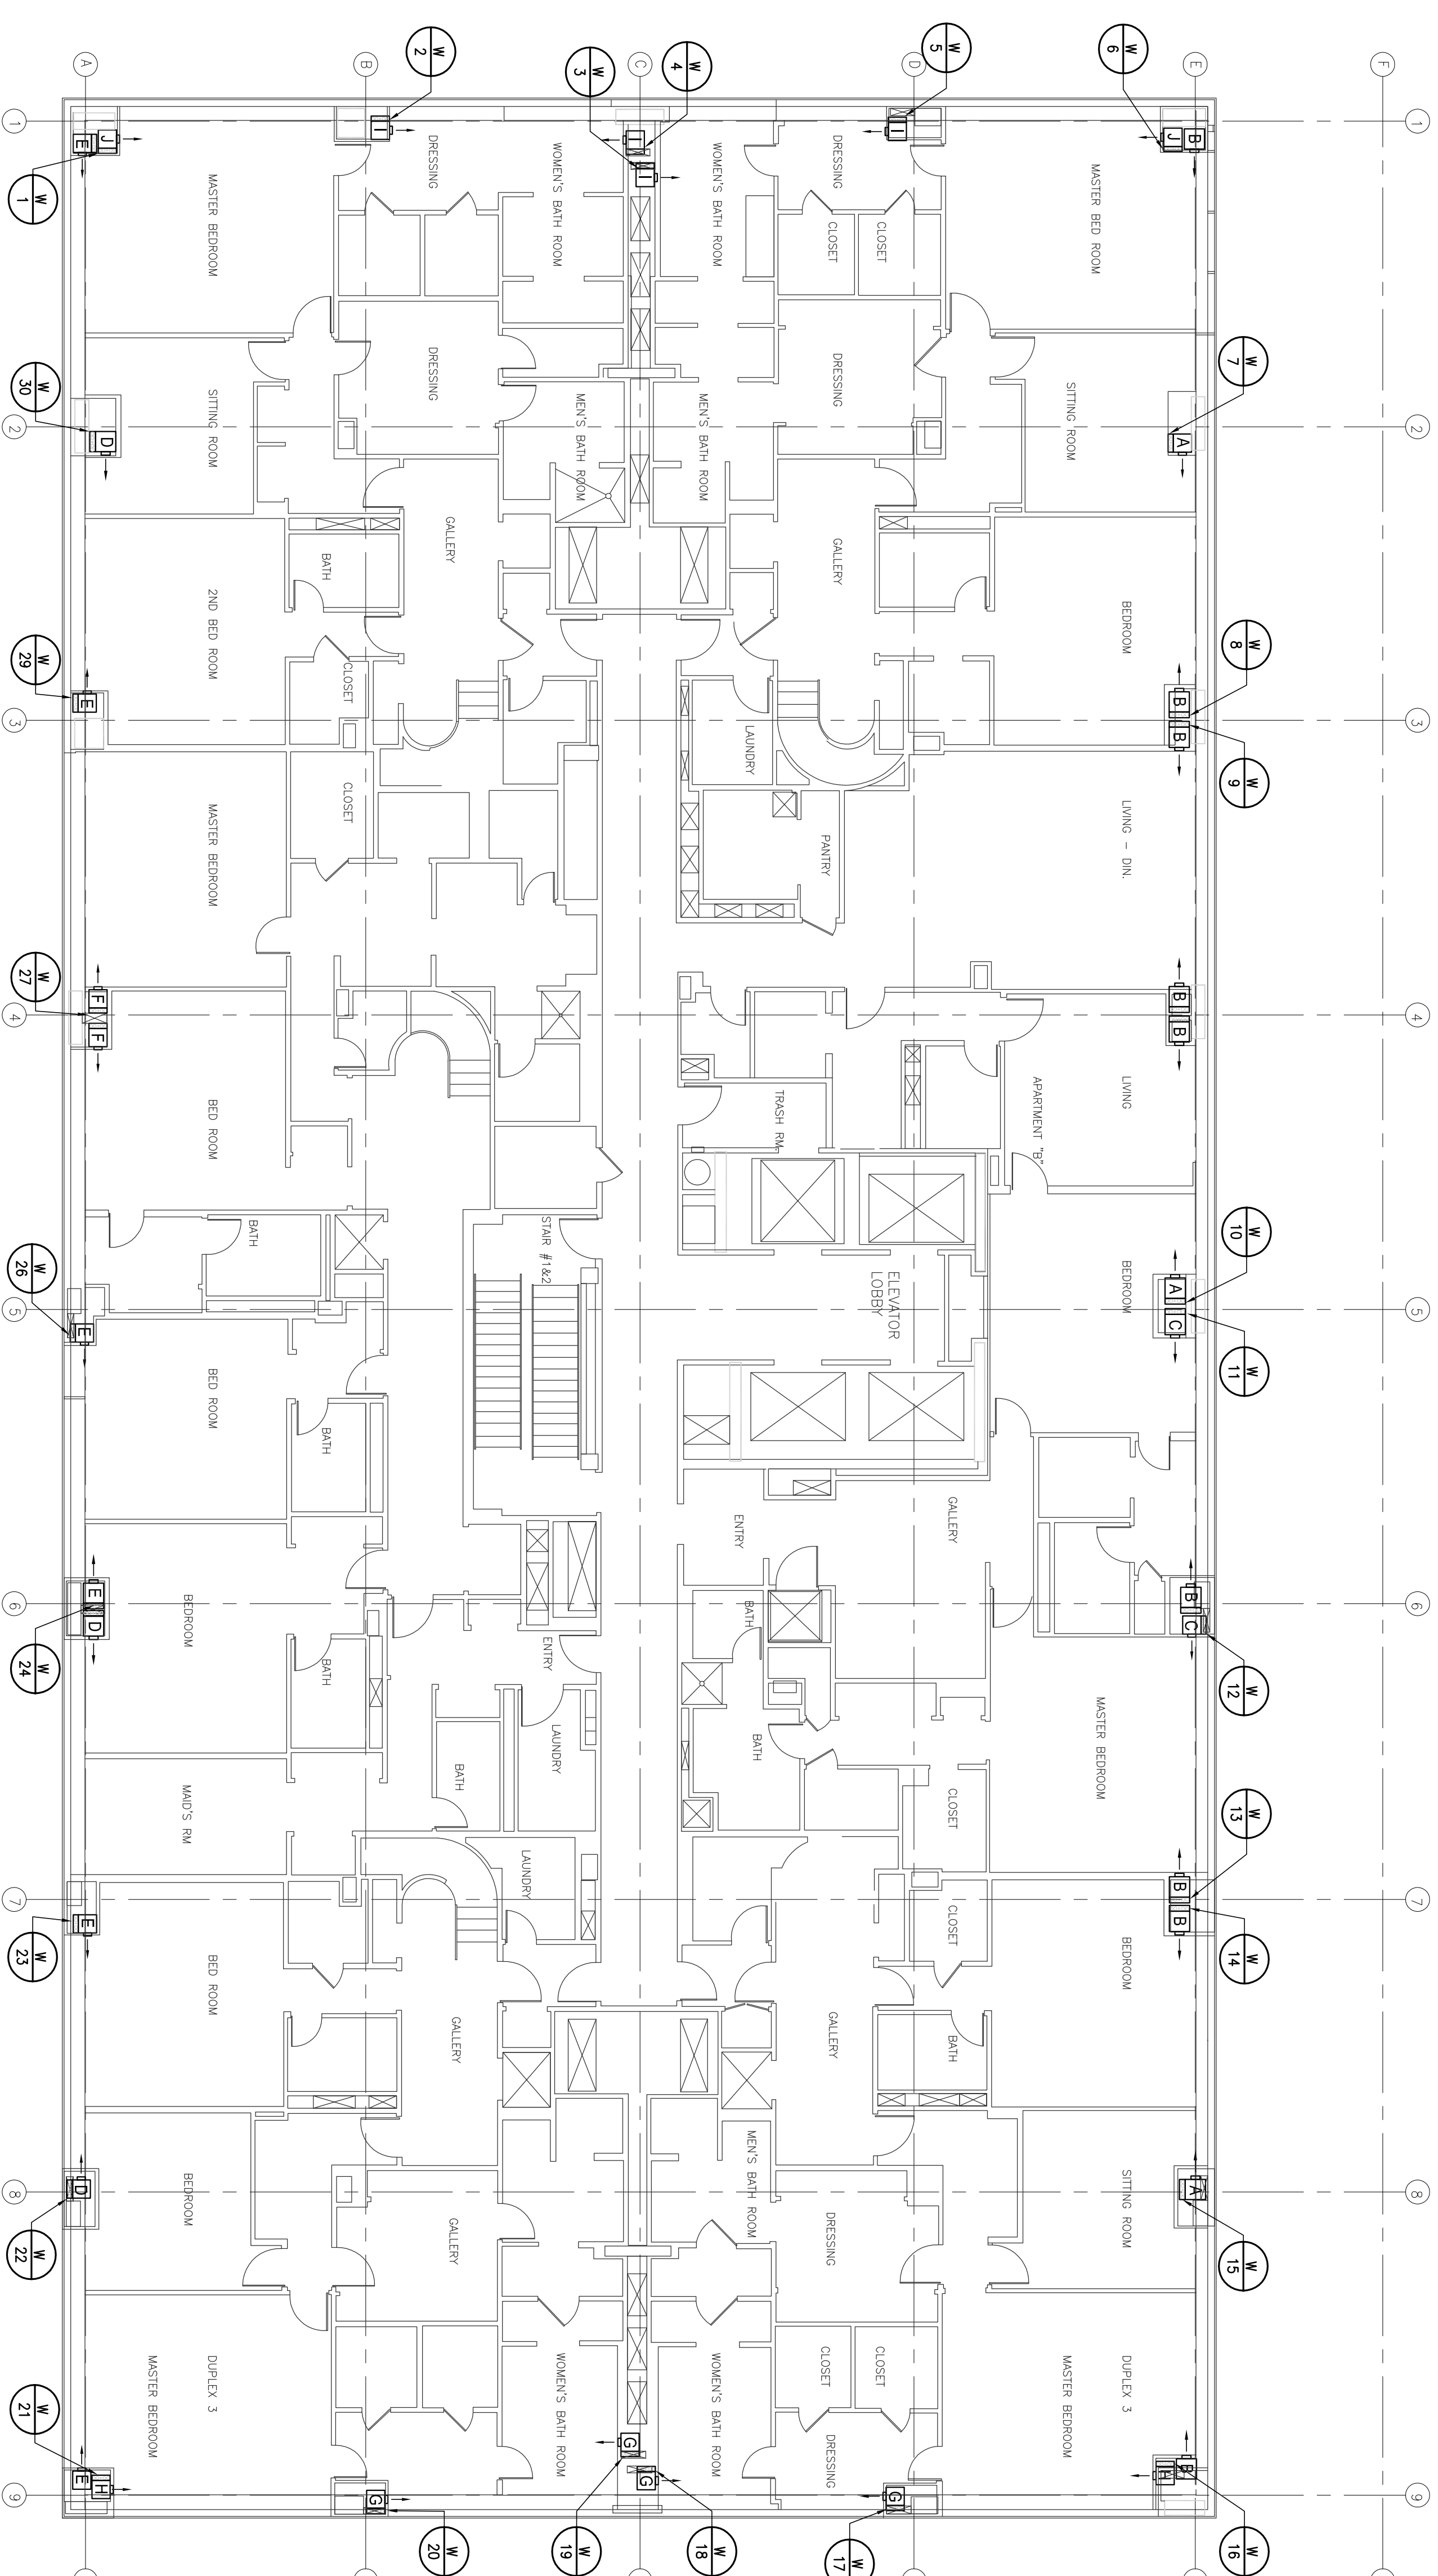

50TH FLOOR MECHANICAL PLAN

---

SCALE:  $\frac{1}{8}" = 1'-0"$

- GENERAL NOTES:**
1. THE PLANS ARE INTENDED TO INDICATE THE GENERAL LOCATION AND FAN COIL UNIT TYPE IN EACH APARTMENT. EXACT UNIT DIMENSIONS, LOCATIONS, & RISER PIPING ARRANGEMENTS MUST BE VERIFIED BY THE INSTALLING CONTRACTOR.
  2. SEE FAN COIL UNIT SCHEDULE FOR UNIT CAPACITIES.
  3. SEE TYPICAL FAN COIL UNIT INSTALLATION DETAIL (DWG M-6) FOR INSTALLATION REQUIREMENTS.

THIS PLAN IS APPROVED ONLY FOR WORK INDICATED ON THE APPLICATION SPECIFICATION SHEET. ALL OTHER MATTERS SHOWN ARE NOT TO BE RELIED UPON, OR TO BE CONSIDERED AS EITHER BEING APPROVED OR IN ACCORDANCE WITH APPLICABLE CODES.